

Date: February 14, 2022

ASI-01

Project: DeIDOT Georgetown Administration Building


Project No: T202180102

SJ Project No: 20069

The work herein shall be considered part of the bid documents for the referenced project and carried out in accordance with the following supplemental instructions issued in accordance with the Contract Documents without change in Contract Sum or Contract Time. Acknowledge receipt of addendum on the bid form as indicated.

Purchase and install (2) diaper changing stations in single bathrooms at Conference Room. Provide pricing for product and installation. See sketch ASK-02 for location.

Changing Table Basis of Design: Bobrick KB200

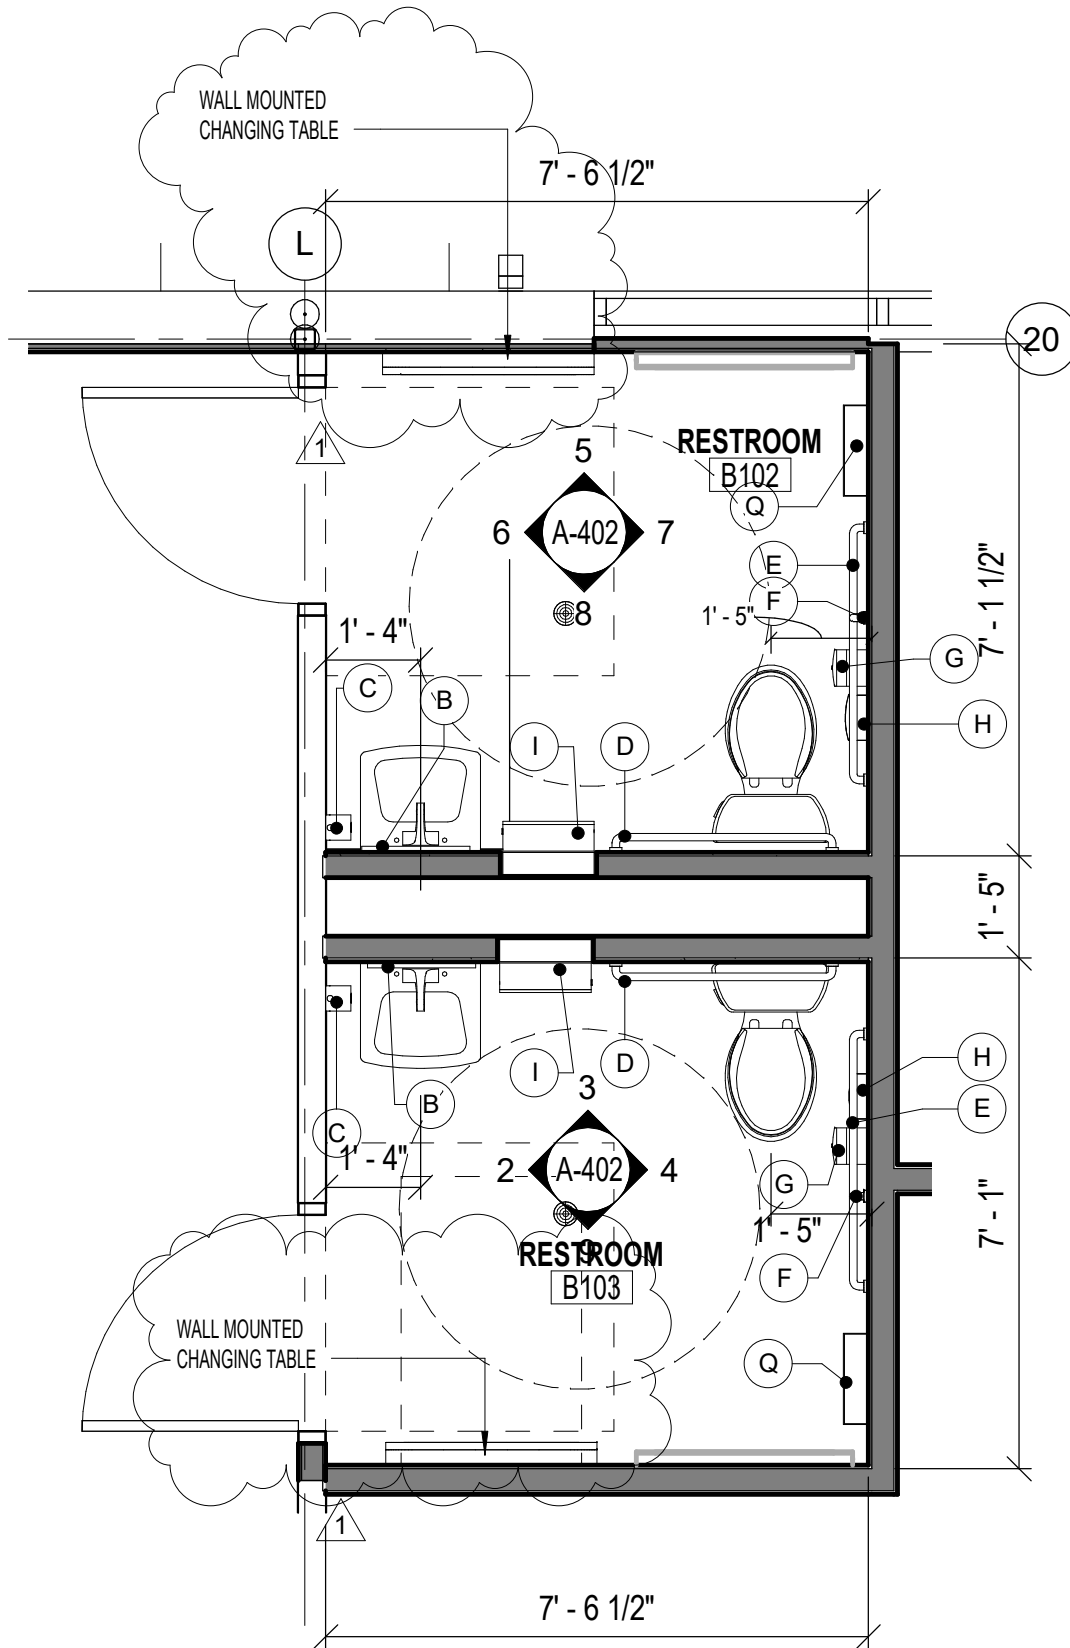

1 ENLARGED TOILET ROOM FLOOR PLANS
 ASK-02 SCALE: 3/8" = 1'-0"

02/14/22 DATE
 20069 PROJECT NO.
 A-402 SHEET NO.
 ASK-02

DELAWARE DEPARTMENT OF TRANSPORTATION
 GEORGETOWN ADMINISTRATION BUILDING
 RENOVATION / EXPANSION
 23697 DUPONT BLVD, GEORGETOWN, DELAWARE 19947

STUDIOJAED
 ARCHITECTS ■ ENGINEERS ■ FACILITIES SOLUTIONS
 DELAWARE OFFICE: 100 PRINCETON WALK ROAD, STE. 110, DEWE, DELAWARE 19721
 PROVIDENCE OFFICE: 60 WESTWOOD STREET, STE. 403, PROVIDENCE, RHODE ISLAND 02903
 MARYLAND OFFICE: 2770 BAY STREET, F.O. BOX 204, COLUMPTON, MARYLAND 21033

PROVIDED AS PART OF THE PROJECT DOCUMENTS. THIS DRAWING IS THE PROPERTY OF STUDIOJAED. IT IS TO BE USED ONLY FOR THE PROJECT AND SITE SPECIFICALLY IDENTIFIED. ANY REUSE OR MODIFICATION OF THIS DRAWING WITHOUT THE WRITTEN PERMISSION OF STUDIOJAED IS STRICTLY PROHIBITED.

ASK-02