

1 2 3 4 5 6

E  
D  
C  
B  
A



- KEYNOTES**
- 1 EXTEND BRANCH CIRCUIT WIRING TO LIGHTING FIXTURE IN ADJACENT COMMONS AREA. SEE SHEET EL-122 FOR CONTINUATION.
  - 2 AREA OF REFUGE ILLUMINATED SIGNAGE. INSTALL WITH BOTTOM OF SIGNAGE NO LESS THAN 8" AFF AND TOP OF SIGNAGE NO MORE THAN 8" AFF.
  - 3 EXTEND BRANCH CIRCUIT WIRING DOWN TO LIGHTED TOGGLE SWITCH IN GYM STORAGE A115. SEE SHEET EL-111 FOR CONTINUATION.
  - 4 PROVIDE LOCKABLE DUST PROOF COVER FOR SWITCH PER SPECIFICATIONS.
  - 5 MOUNT LIGHTING FIXTURE APPROXIMATELY 8" ABOVE STAIR LANDING.
  - 6 EXTEND BRANCH CIRCUIT WIRING TO NORMAL LIGHTING FIXTURE AT BOTTOM OF STAIRWELL. SEE SHEET EL-111 FOR CONTINUATION.
  - 7 EXTEND BRANCH CIRCUIT WIRING TO NORMAL LIGHTING FIXTURE AT TOP OF STAIRWELL. SEE SHEET EL-131 FOR CONTINUATION.
  - 8 EXTEND BRANCH CIRCUIT WIRING TO LIGHTING FIXTURE WIRED THROUGH INVERTER AT BOTTOM OF STAIRWELL. SEE SHEET EL-111 FOR CONTINUATION.
  - 9 EXTEND BRANCH CIRCUIT WIRING TO LIGHTING FIXTURE WIRED THROUGH INVERTER AT TOP OF STAIRWELL. SEE SHEET EL-131 FOR CONTINUATION.
  - 10 INSTALL LIGHTING FIXTURE APPROXIMATELY 34"-9" AFG, HALFWAY BETWEEN TOP OF LCPD AND BOTTOM OF ILLUMINATED SIGNAGE. LETTERING CENTERED OVER SIGNAGE.
  - 11 REMOTE POWER SUPPLY FOR TYPE V 3 LUMINAIRES FED FROM INVERTER. LOCATED ABOVE ACCESSIBLE CEILING. SEE ELEVATION 3/E-205 FOR LUMINAIRE QUANTITY / LOCATIONS.
  - 12 REMOTE POWER SUPPLY FOR TYPE V 3 LUMINAIRES ON NORMAL POWER ONLY. LOCATED ABOVE ACCESSIBLE CEILING. SEE ELEVATION 3/E-205 FOR LUMINAIRE QUANTITY / LOCATIONS.



1621 N. Lincoln Street  
Wilmington, DE 19806  
(P) 302.658.6426  
(F) 302.658.8431  
abhagen@ABHA.com  
www.ABHA.com

CONSULTANTS  
Davis Bowen & Friedel, Inc.  
Civil Engineer


Pilottown Engineering  
Structural Engineer

Activitas, Inc.  
Landscape Architect

GIPE Associates  
MEP Engineer

Stages  
Theater & Acoustic Consultant

Corsi Associates  
Food Service Consultant

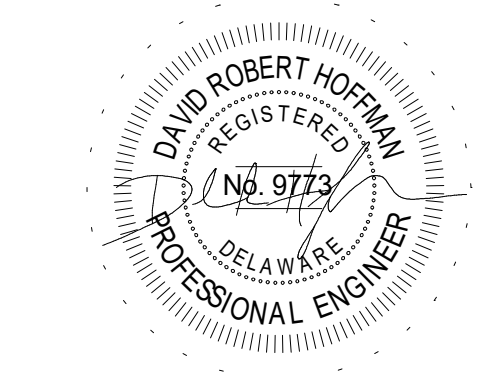


PROJECT  
NEW MIDDLE SCHOOL

910 SHIELDS AVENUE  
LEWES, DE 19958

OWNER  
CAPE HENLOPEN  
SCHOOL DISTRICT

1270 KINGS HWY  
LEWES, DE 19585

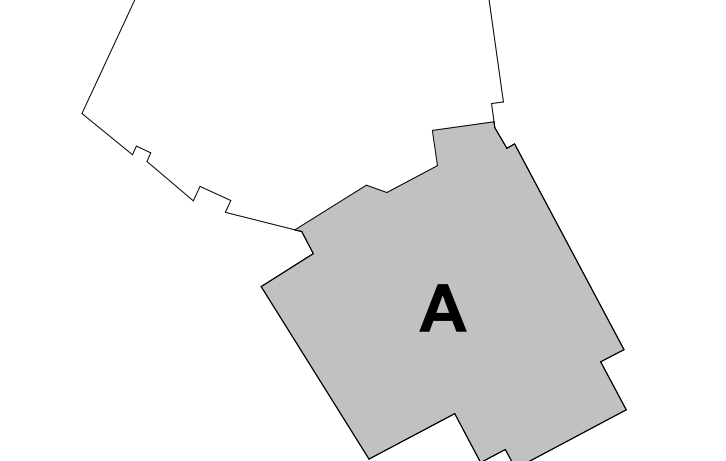

MARK	DATE	DESCRIPTION
3	11/30/2022	ASI-017
2	10/03/2022	ASI-005R
1	05/17/2022	CONFORMANCE SET


PROJECT NUMBER: 2020-14  
FILE NAME: CHMS\_Arch\_v2020.rvt  
DRAWN BY: MPV  
CHECKED BY: CDH

The professional services of ABHA Architects, Inc. are undertaken for and performed in the interest of Cape Henlopen School District. No contractual obligation is assumed by ABHA Architects, Inc. for the benefit of any other person involved in the project.  
These documents are owned by ABHA Architects, Inc. and shall not be used without written permission. Copyright ABHA Architects, Inc. © 2021

SHEET TITLE  
SECOND FLOOR PLAN -  
AREA 'A' - LIGHTING

**EL-121**

 1 SECOND FLOOR PLAN - AREA 'A' - LIGHTING  
1/8" = 1'-0"



1 2 3 4 5 6