

**Addendum  
No. 4**

Addendum Date: July 10, 2023  
Project: Admin Building HVAC Replacement  
DeIDOT Administration Building  
SJ Project No: 19121

---

The work herein shall be considered part of the bid documents for the referenced project and carried out in accordance with the following supplemental instructions issued in accordance with the Contract Documents without change in Contract Sum or Contract Time. Acknowledge receipt of addendum on the bid form as indicated.

---

**Clarifications:**

None at this time.

**Questions / Responses:**

None at this time.

**Changes to Drawings:**


1. Drawing H-103 – Hydronic Roof Plan
  - a. Revise scale from [1/16" = 1'-0"] to [1/8" = 1'-0"].
  - b. No revised drawing issued with addendum, change will be reflected on future drawing issues.
2. Drawing E101A – First Floor New Work Plan – Area A
  - a. Removed rooftop scope of work text box – moved scope to sheet E-103.
3. Drawing E102A – Second Floor New Work Plan – Area A
  - a. Removed rooftop scope of work text box – moved scope to sheet E-103.
4. Drawing E-103 – Roof Electrical Plan
  - a. Added sheet showing rooftop electrical scope.

**Attachments:**


1. Drawing E101A – First Floor New Work Plan – Area A
2. Drawing E102A – Second Floor New Work Plan – Area A
3. Drawing E-103 – Roof Electrical Plan

END

THE RECORDS OF THIS PROJECT ARE THE PROPERTY OF STUDIOJAED ARCHITECTS & ENGINEERS. NO PART OF THESE RECORDS SHALL BE REPRODUCED OR TRANSMITTED IN ANY FORM OR BY ANY MEANS, ELECTRONIC OR MECHANICAL, INCLUDING PHOTOCOPYING, RECORDING, OR BY ANY INFORMATION STORAGE AND RETRIEVAL SYSTEM, WITHOUT THE WRITTEN PERMISSION OF STUDIOJAED ARCHITECTS & ENGINEERS. THE RECORDS OF THIS PROJECT ARE THE PROPERTY OF STUDIOJAED ARCHITECTS & ENGINEERS. NO PART OF THESE RECORDS SHALL BE REPRODUCED OR TRANSMITTED IN ANY FORM OR BY ANY MEANS, ELECTRONIC OR MECHANICAL, INCLUDING PHOTOCOPYING, RECORDING, OR BY ANY INFORMATION STORAGE AND RETRIEVAL SYSTEM, WITHOUT THE WRITTEN PERMISSION OF STUDIOJAED ARCHITECTS & ENGINEERS.

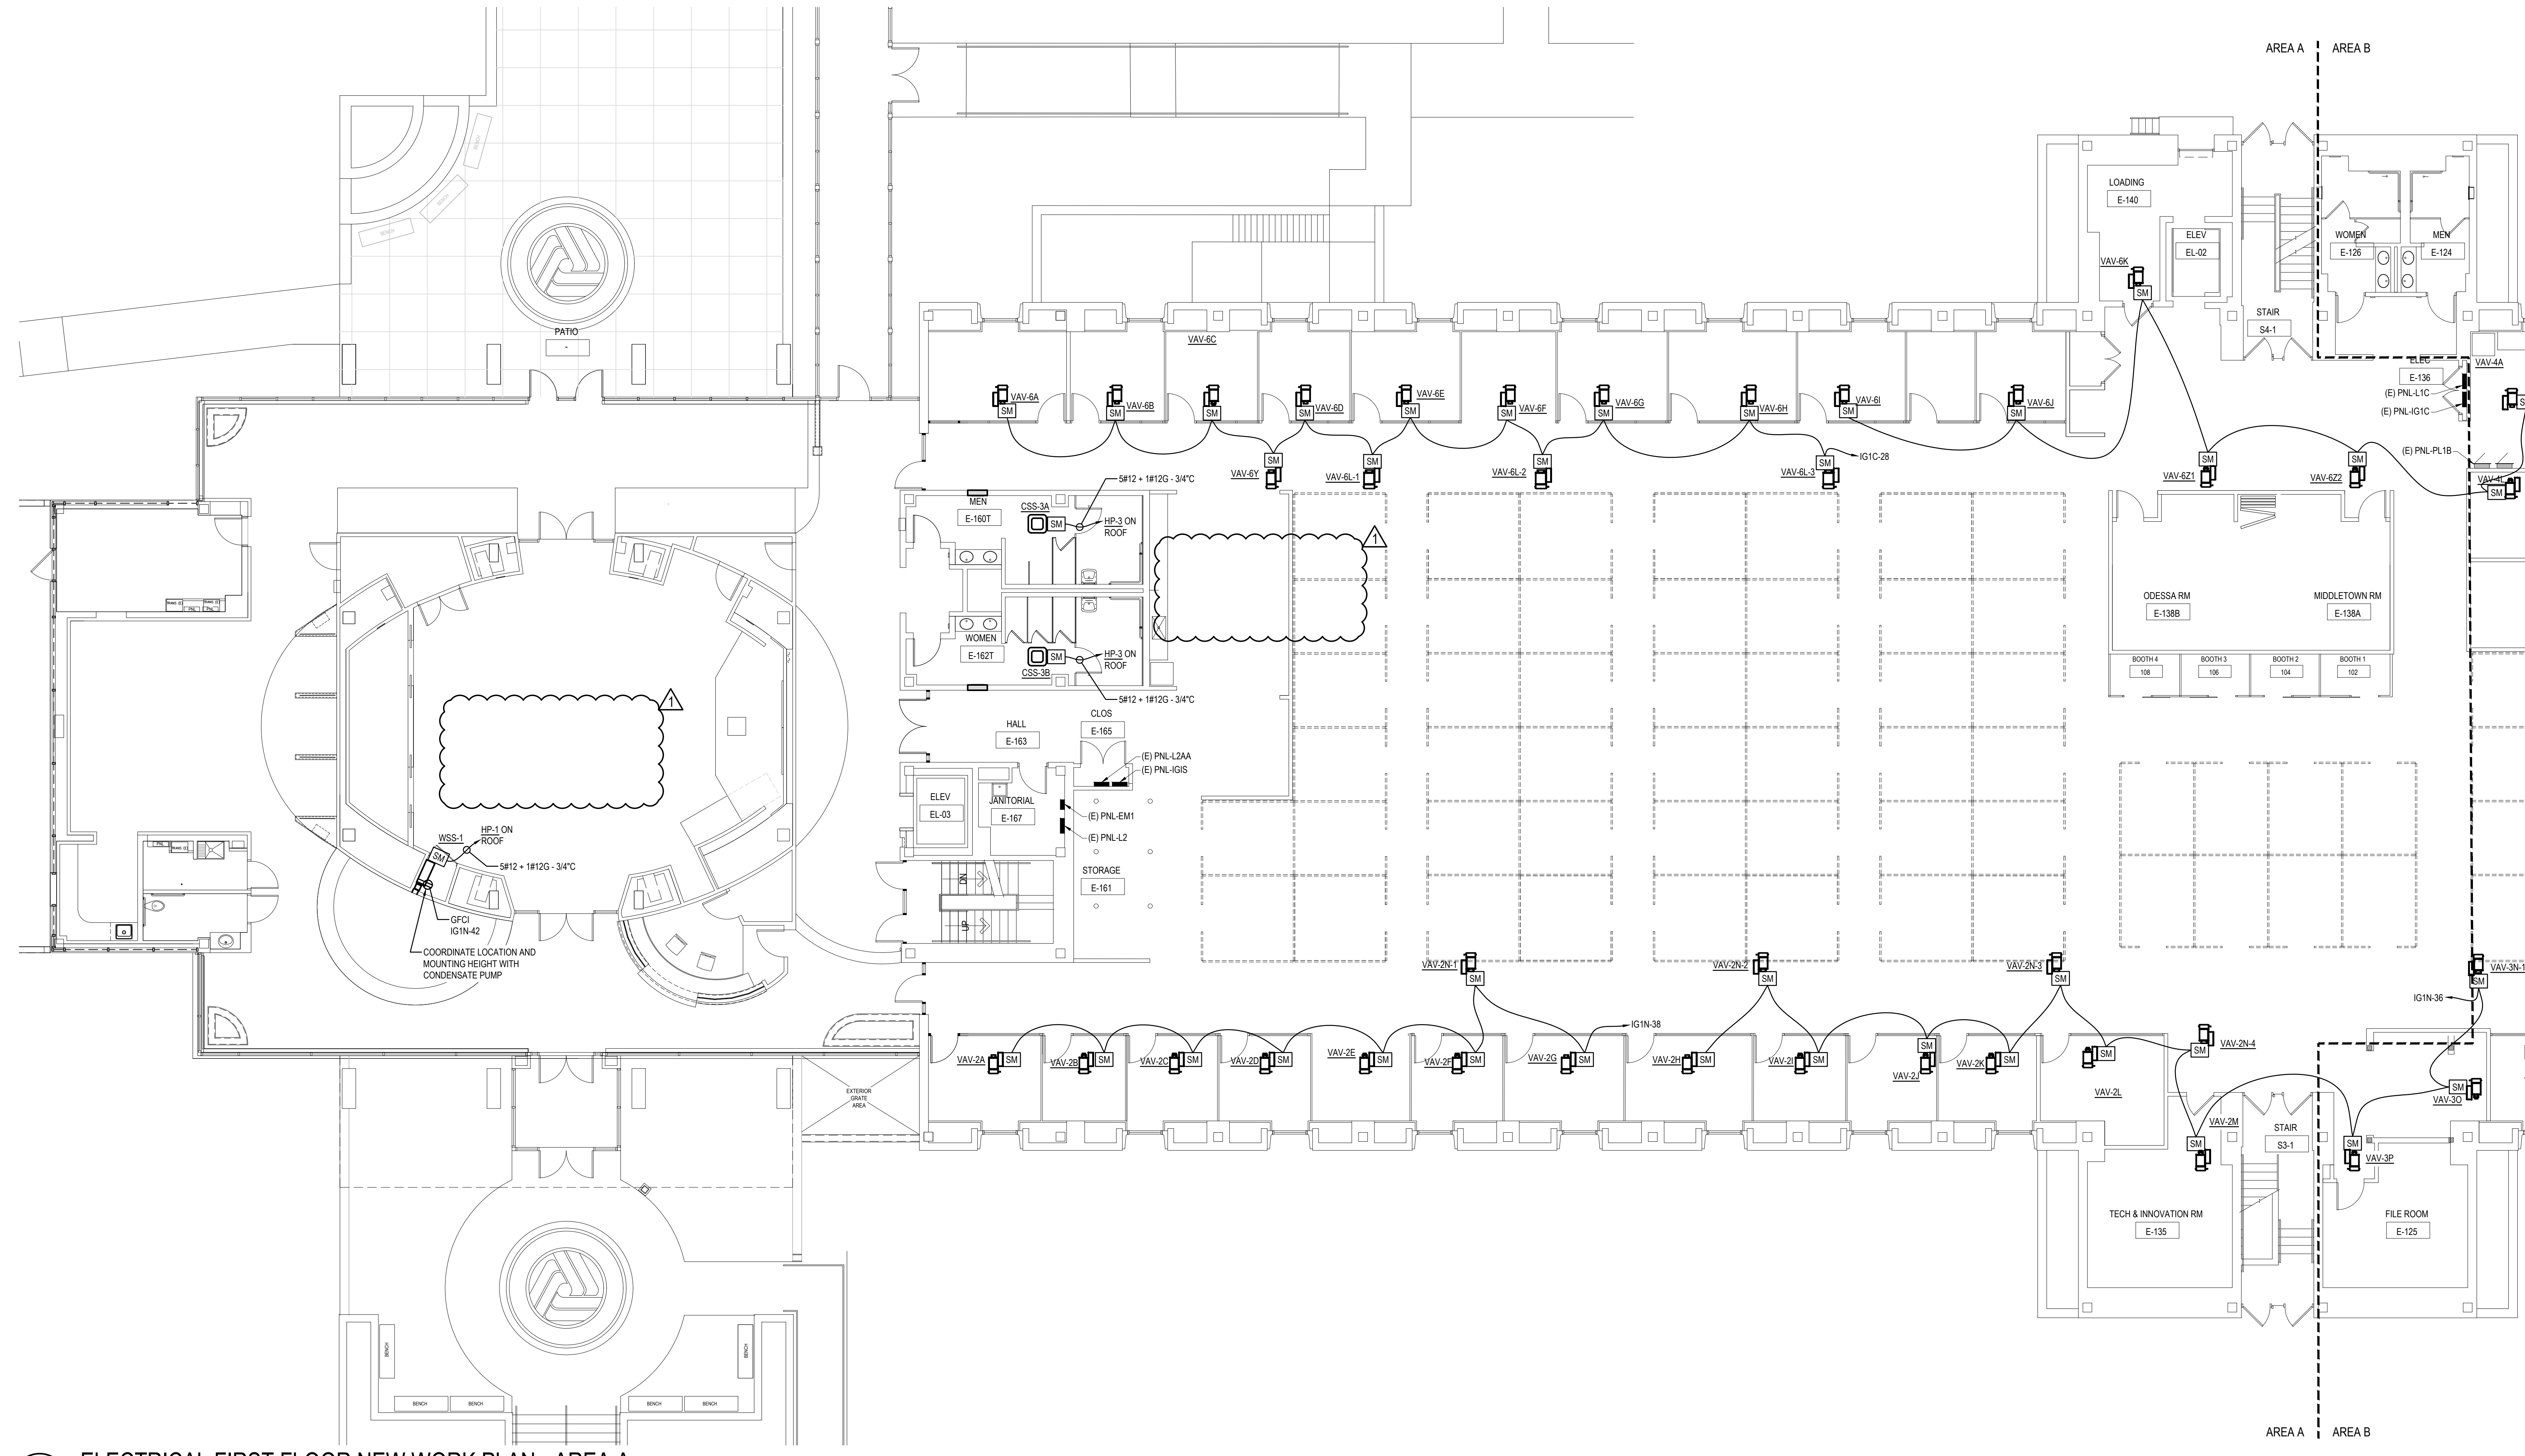

**1** ELECTRICAL FIRST FLOOR NEW WORK PLAN - AREA A  
 E101A SCALE: 1/8" = 1'-0"

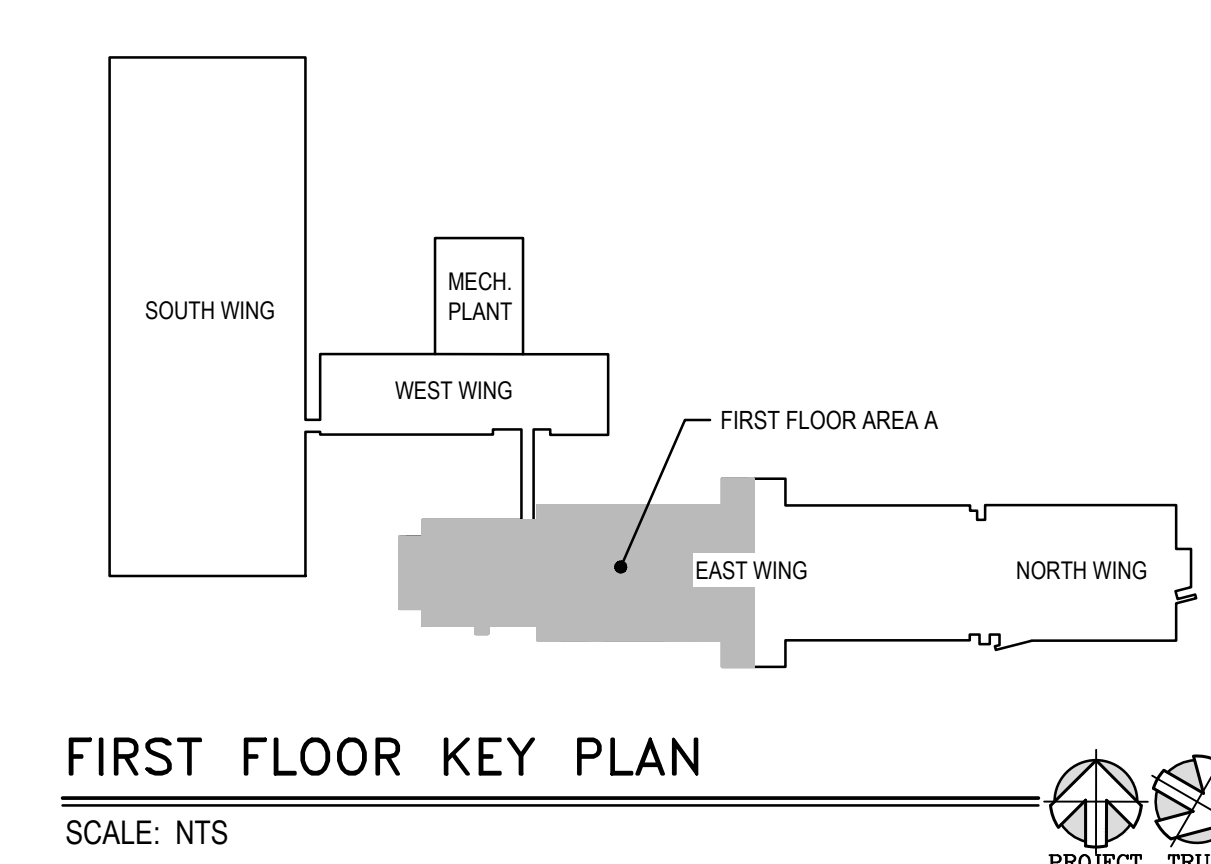

FIRST FLOOR KEY PLAN  
 SCALE: NTS

**STUDIOJAED**  
 ARCHITECTS & ENGINEERS FACILITIES SOLUTIONS  
 Website: www.studiojaed.com Email: info@studiojaed.com  
 DELAWARE OFFICE: 250 W. WAREHOUSING HILL ROAD, STE. 110, CHRISTIANA, DE 19701, P. 302.383.4525  
 PROVIDENCE OFFICE: 47 W. BOSSETT STREET, STE. 403, PROVIDENCE, RI 02903, P. 401.848.8888  
 MARYLAND OFFICE: 275 FRONT STREET, P.O. BOX 254, CHANTON, MARYLAND 21550

CONSULTANT  
 THIS DRAWING IS THE PROPERTY OF STUDIOJAED ARCHITECTS & ENGINEERS. NO PART OF THIS DRAWING SHALL BE REPRODUCED OR TRANSMITTED IN ANY FORM OR BY ANY MEANS, ELECTRONIC OR MECHANICAL, INCLUDING PHOTOCOPYING, RECORDING, OR BY ANY INFORMATION STORAGE AND RETRIEVAL SYSTEM, WITHOUT THE WRITTEN PERMISSION OF STUDIOJAED ARCHITECTS & ENGINEERS.


ARCHITECT / ENGINEER SEAL

PROJECT  
 OMB / DIVISION OF FACILITIES MANAGEMENT  
 OMB / DFM PROJECT NO. M.6511000003C  
**EAST WING HVAC REPLACEMENT**  
 HIGHWAY ADMINISTRATION BUILDING  
 800 S BAY RD. DOVER, DELAWARE 19901


REVISIONS		
MARK	DESCRIPTION	DATE
1	ADDENDUM #4	7.10.23

SHEET TITLE  
**FIRST FLOOR NEW WORK PLAN - AREA A**  
**BIDDING DOCUMENTS**  
 FEBRUARY 14, 2023  
 DRAWN: JD CHKD: PP PROJECT NO. 19121  
 SHEET NO. **E101A**

THE RECORDS OF THIS PROJECT WILL BE MAINTAINED AT THE PROJECT OFFICE. THE RECORDS WILL BE MAINTAINED FOR A PERIOD OF 10 YEARS FROM THE DATE OF COMPLETION OF THE PROJECT. THE RECORDS WILL BE MAINTAINED IN THE PROJECT OFFICE OR IN A SECURE LOCATION AS DETERMINED BY THE ARCHITECT. THE ARCHITECT SHALL BE RESPONSIBLE FOR THE PROTECTION AND SECURITY OF THE RECORDS. THE ARCHITECT SHALL BE RESPONSIBLE FOR THE PROTECTION AND SECURITY OF THE RECORDS. THE ARCHITECT SHALL BE RESPONSIBLE FOR THE PROTECTION AND SECURITY OF THE RECORDS.

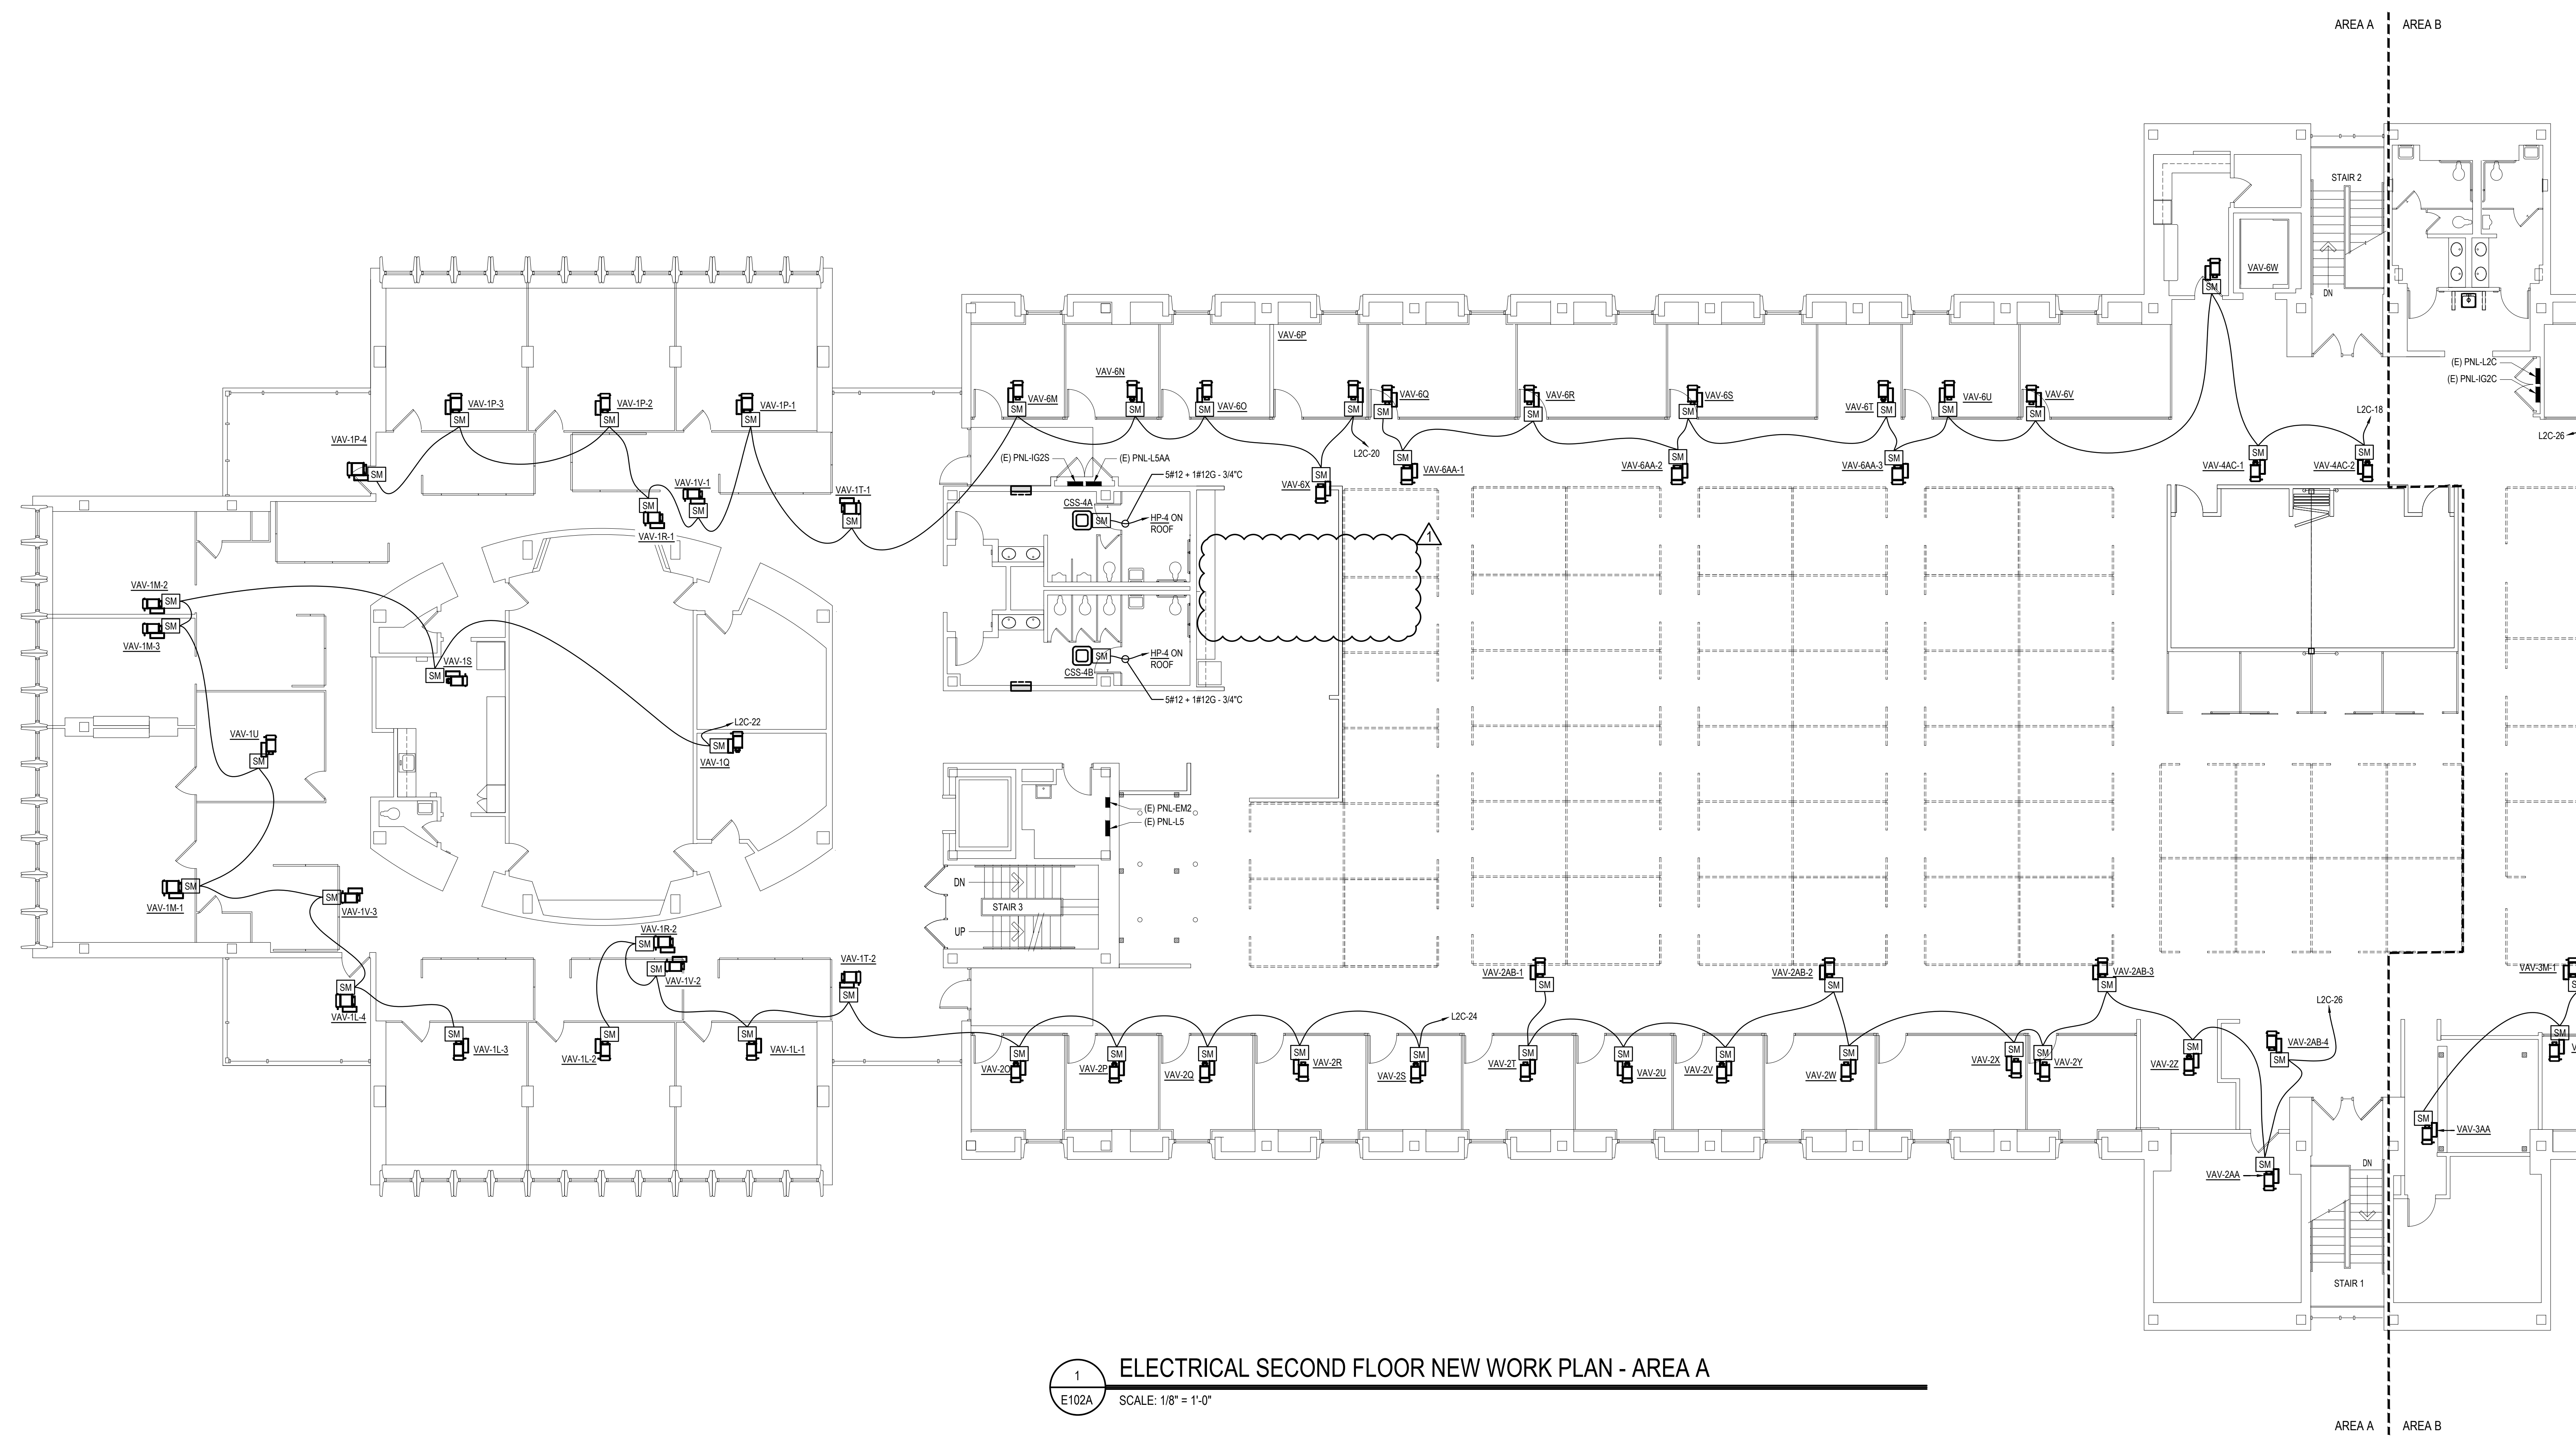

**1**  
**E102A** **ELECTRICAL SECOND FLOOR NEW WORK PLAN - AREA A**  
 SCALE: 1/8" = 1'-0"

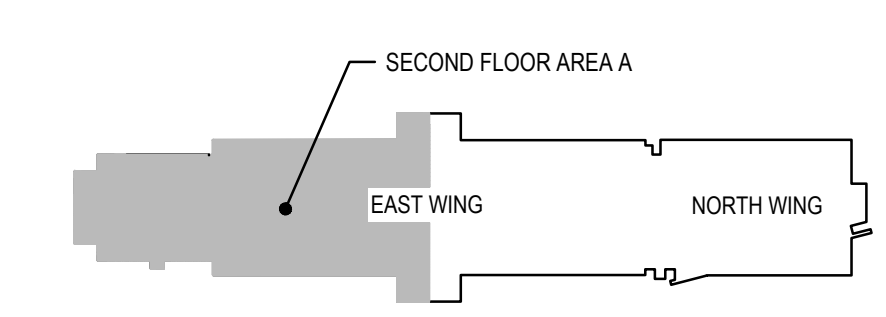

**SECOND FLOOR KEY PLAN**  
 SCALE: NTS

**STUDIOJAED**  
 ARCHITECTS & ENGINEERS & FACILITIES SOLUTIONS  
 EST. 1991  
 DELAWARE OFFICE  
 250 W. WINDLE HILL ROAD, STE. 110  
 WILMINGTON, DE 19801  
 P: 302.433.4525  
 MARYLAND OFFICE  
 275 FRONT STREET, STE. 403  
 CHARTERS MARSH AND ISLANDS  
 P: 410.658.5588  
 Email: info@studiojaed.com  
 Website: www.studiojaed.com


CONSULTANT  
 THIS DRAWING IS THE PROPERTY OF STUDIOJAED, AND IS PREPARED FOR THE EXCLUSIVE USE OF ITS CLIENTS AT THE LOCATION INDICATED. NO OTHER USE IS AUTHORIZED OR INTENDED.  
 ARCHITECT / ENGINEER SEAL

PROJECT  
 OMB / DIVISION OF FACILITIES MANAGEMENT  
 OMB / DFM PROJECT NO. MJ551100003C  
**EAST WING HVAC REPLACEMENT**  
 HIGHWAY ADMINISTRATION BUILDING  
 800 S BAY RD., DOVER, DELAWARE 19901


REVISIONS		
MARK	DESCRIPTION	DATE
1	ADDENDUM #4	7.10.23

SHEET TITLE  
**SECOND FLOOR NEW WORK PLAN - AREA A**  
 BIDDING DOCUMENTS  
 FEBRUARY 14, 2023  
 DRAWN: JD  
 CHKD: PP  
 PROJECT NO.: 19121  
 SHEET NO.: **E102A**

THE RECEIVER OF THESE PLANS IS HEREBY ADVISED THAT THE INFORMATION CONTAINED HEREIN IS FOR GENERAL INFORMATION ONLY AND DOES NOT CONSTITUTE A CONTRACT. THE RECEIVER SHALL BE RESPONSIBLE FOR VERIFYING ALL INFORMATION AND DATA. THE RECEIVER SHALL BE RESPONSIBLE FOR VERIFYING ALL INFORMATION AND DATA. THE RECEIVER SHALL BE RESPONSIBLE FOR VERIFYING ALL INFORMATION AND DATA.

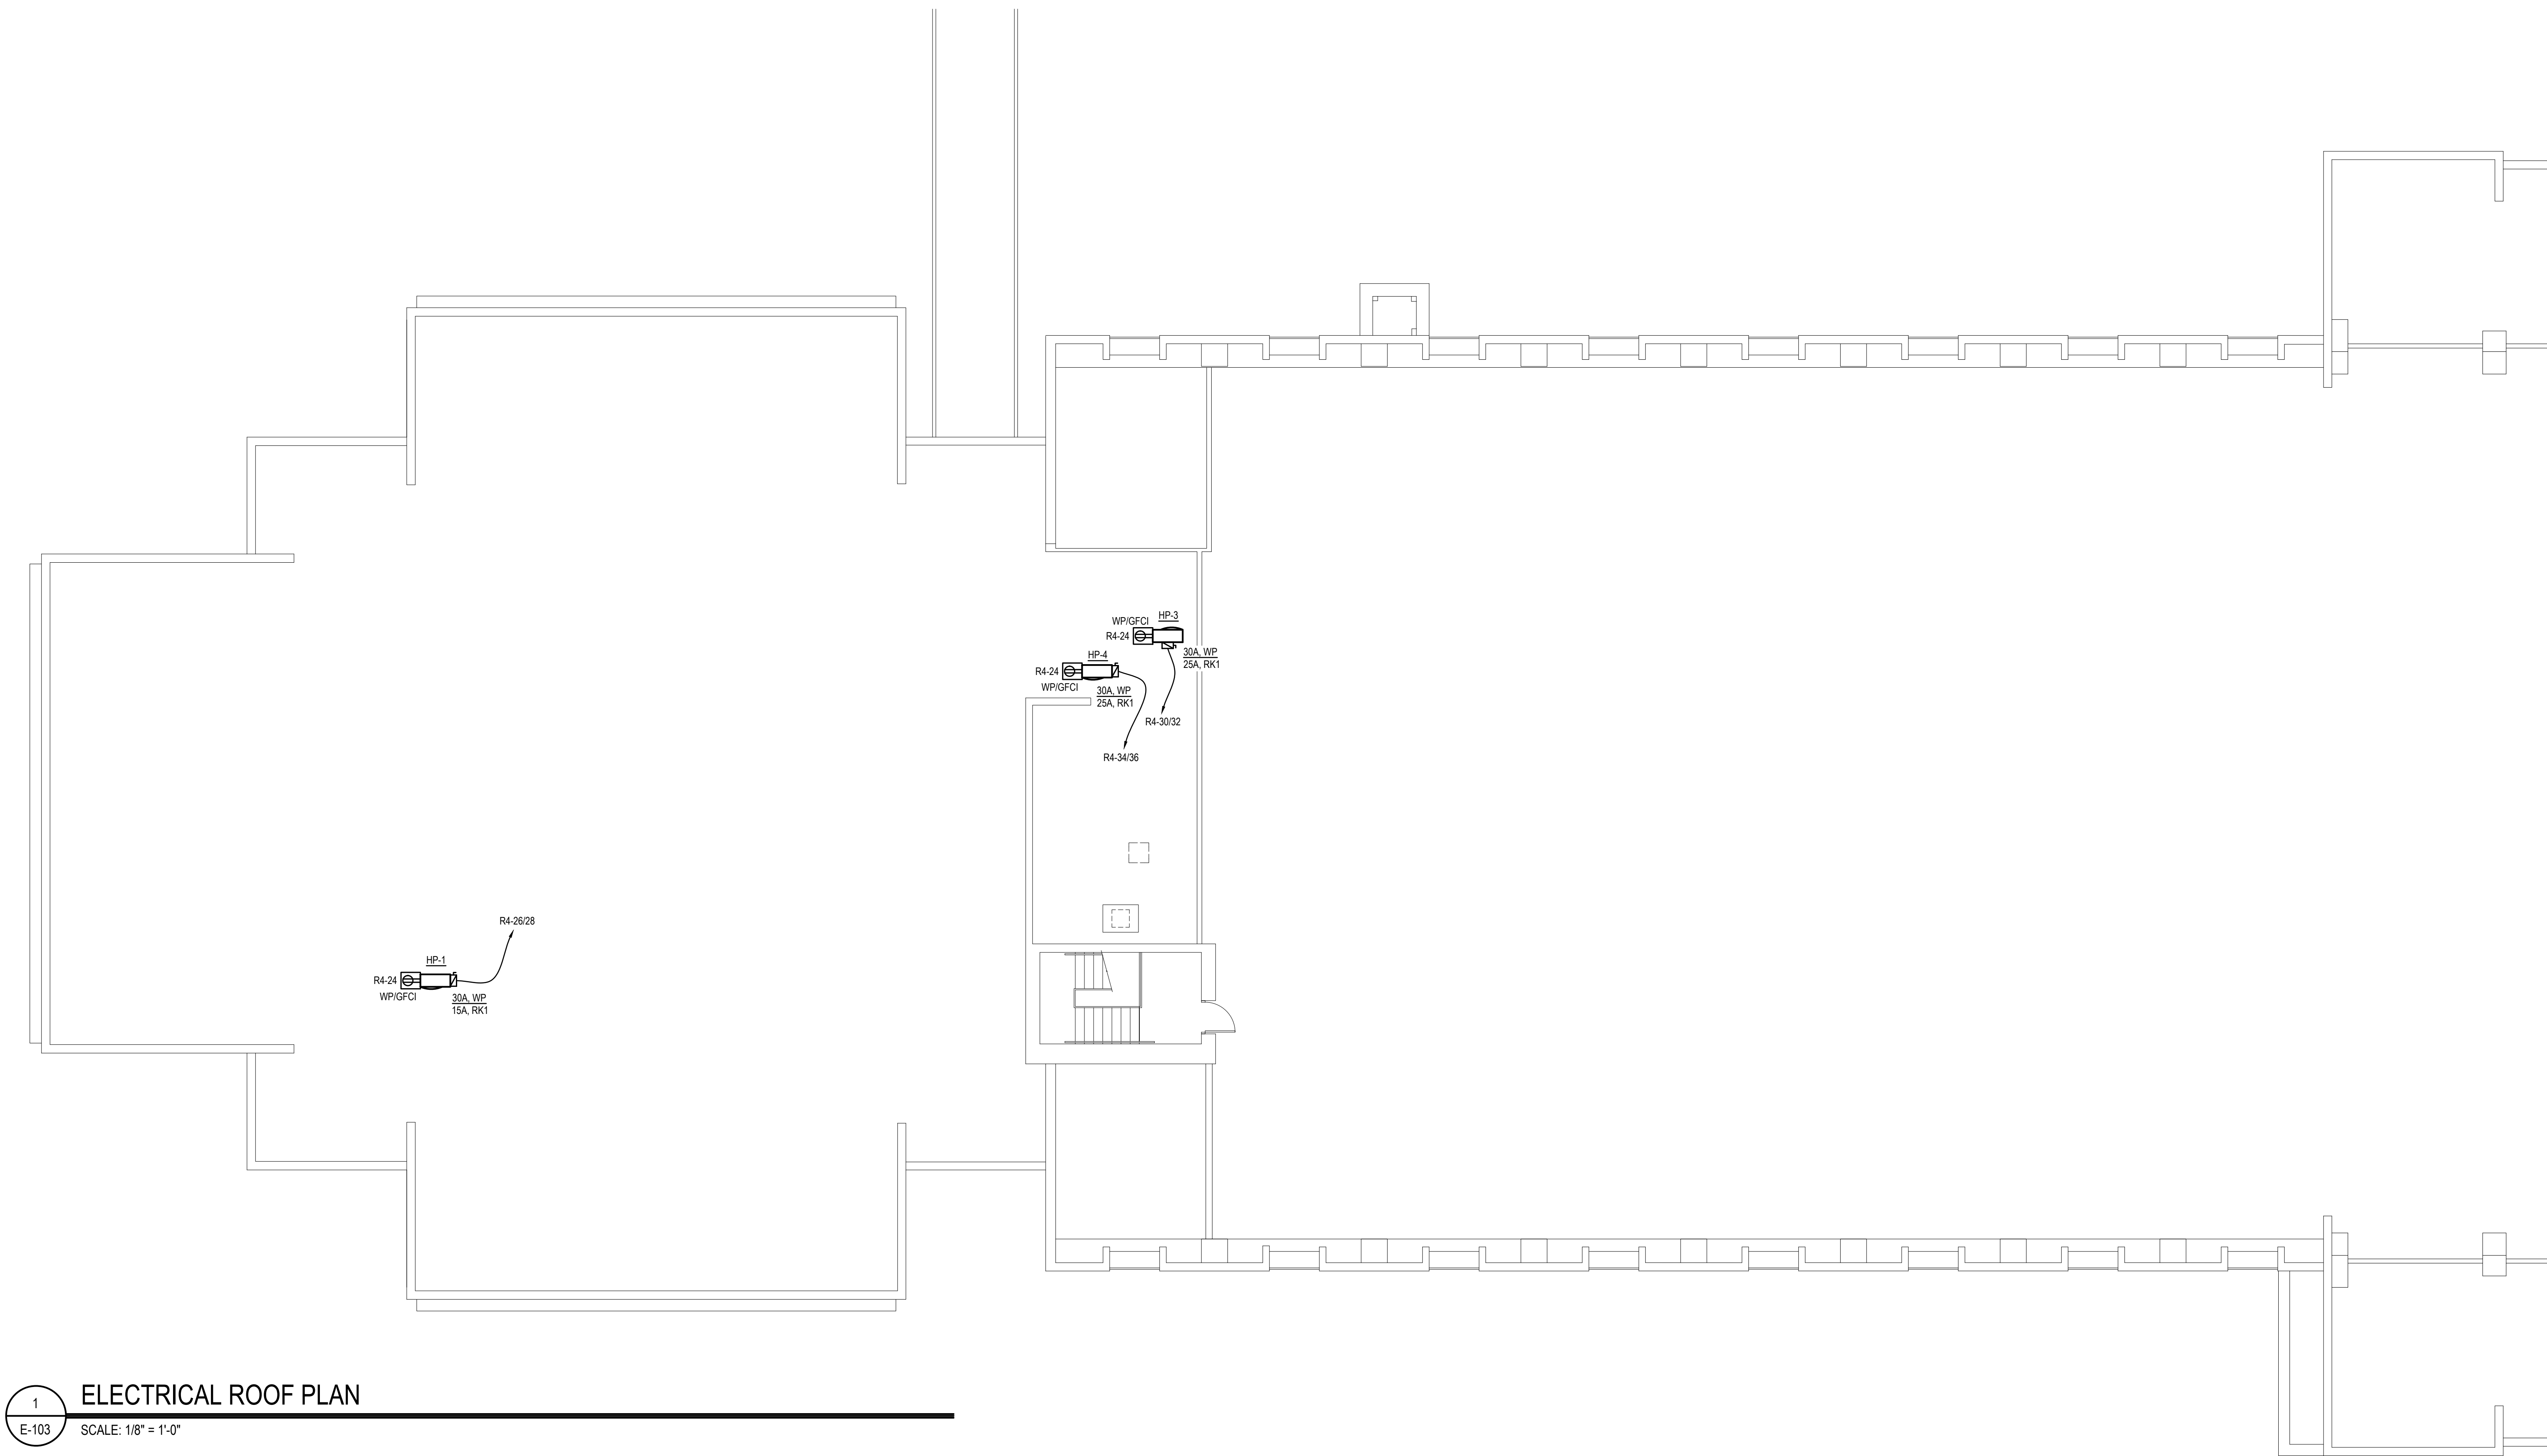

**1**  
**ELECTRICAL ROOF PLAN**  
 E-103 SCALE: 1/8" = 1'-0"

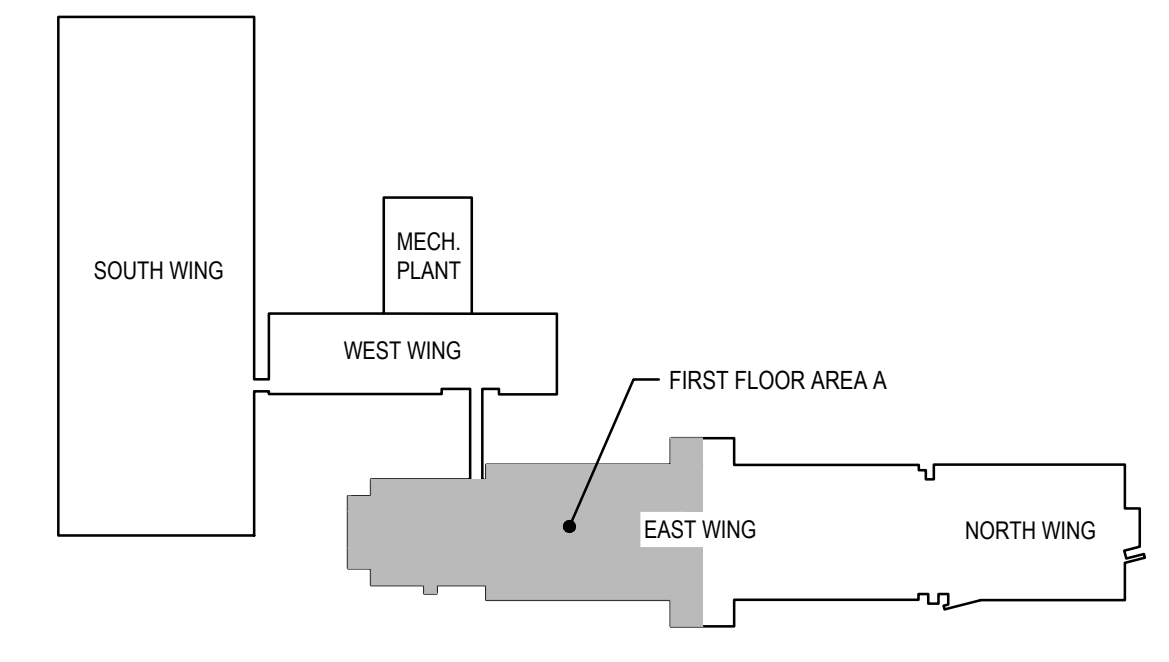

**ROOF KEY PLAN**  
 SCALE: NTS

**STUDIO JAED**  
 ARCHITECTS & ENGINEERS FACILITIES SOLUTIONS  
 Website: www.StudioJAED.com

DELAWARE OFFICE  
 1000 N. MARKET ST. STE. 110  
 DEWESBORO, DE 19844  
 P: (302) 832-1622

PENNSYLVANIA OFFICE  
 1000 N. MARKET ST. STE. 110  
 DEWESBORO, PA 19340  
 P: (610) 648-0884

MARYLAND OFFICE  
 1000 N. MARKET ST. STE. 110  
 DEWESBORO, MD 21040  
 P: (410) 648-0884

CONSULTANT

THIS DRAWING IS THE PROPERTY OF STUDIO JAED, AND IS PREPARED FOR THE EXCLUSIVE USE OF ITS CLIENTS AT THE LOCATION INDICATED. NO OTHER USE IS AUTHORIZED OR INTENDED.

ARCHITECT / ENGINEER SEAL

PROJECT  
 OMB / DIVISION OF FACILITIES MANAGEMENT  
 OMB / DFM PROJECT NO. IM6511000003C  
**EAST WING HVAC REPLACEMENT**  
 HIGHWAY ADMINISTRATION BUILDING  
 800 S BAY RD. COVER, DELAWARE 19901

REVISIONS		
MARK	DESCRIPTION	DATE
1	ADDENDUM #4	7-10-23

SHEET TITLE

ROOF ELECTRICAL PLAN

**BIDDING DOCUMENTS**  
 FEBRUARY 14, 2023

DRAWN	CHK'D	PROJECT NO.
JD	PP	19121

SHEET NO.  
**E-103**

